


DAYTONA BEACH NEWS JOURNAL NEW WAREHOUSE ADDITION

OWNER:
 HALIFAX MEDIA HOLDINGS, L.L.C.
 MICHAEL REDDING, CEO
 DBA:
 NEWS JOURNAL
 901 SIXTH STREET
 DAYTONA BEACH,
 FLORIDA

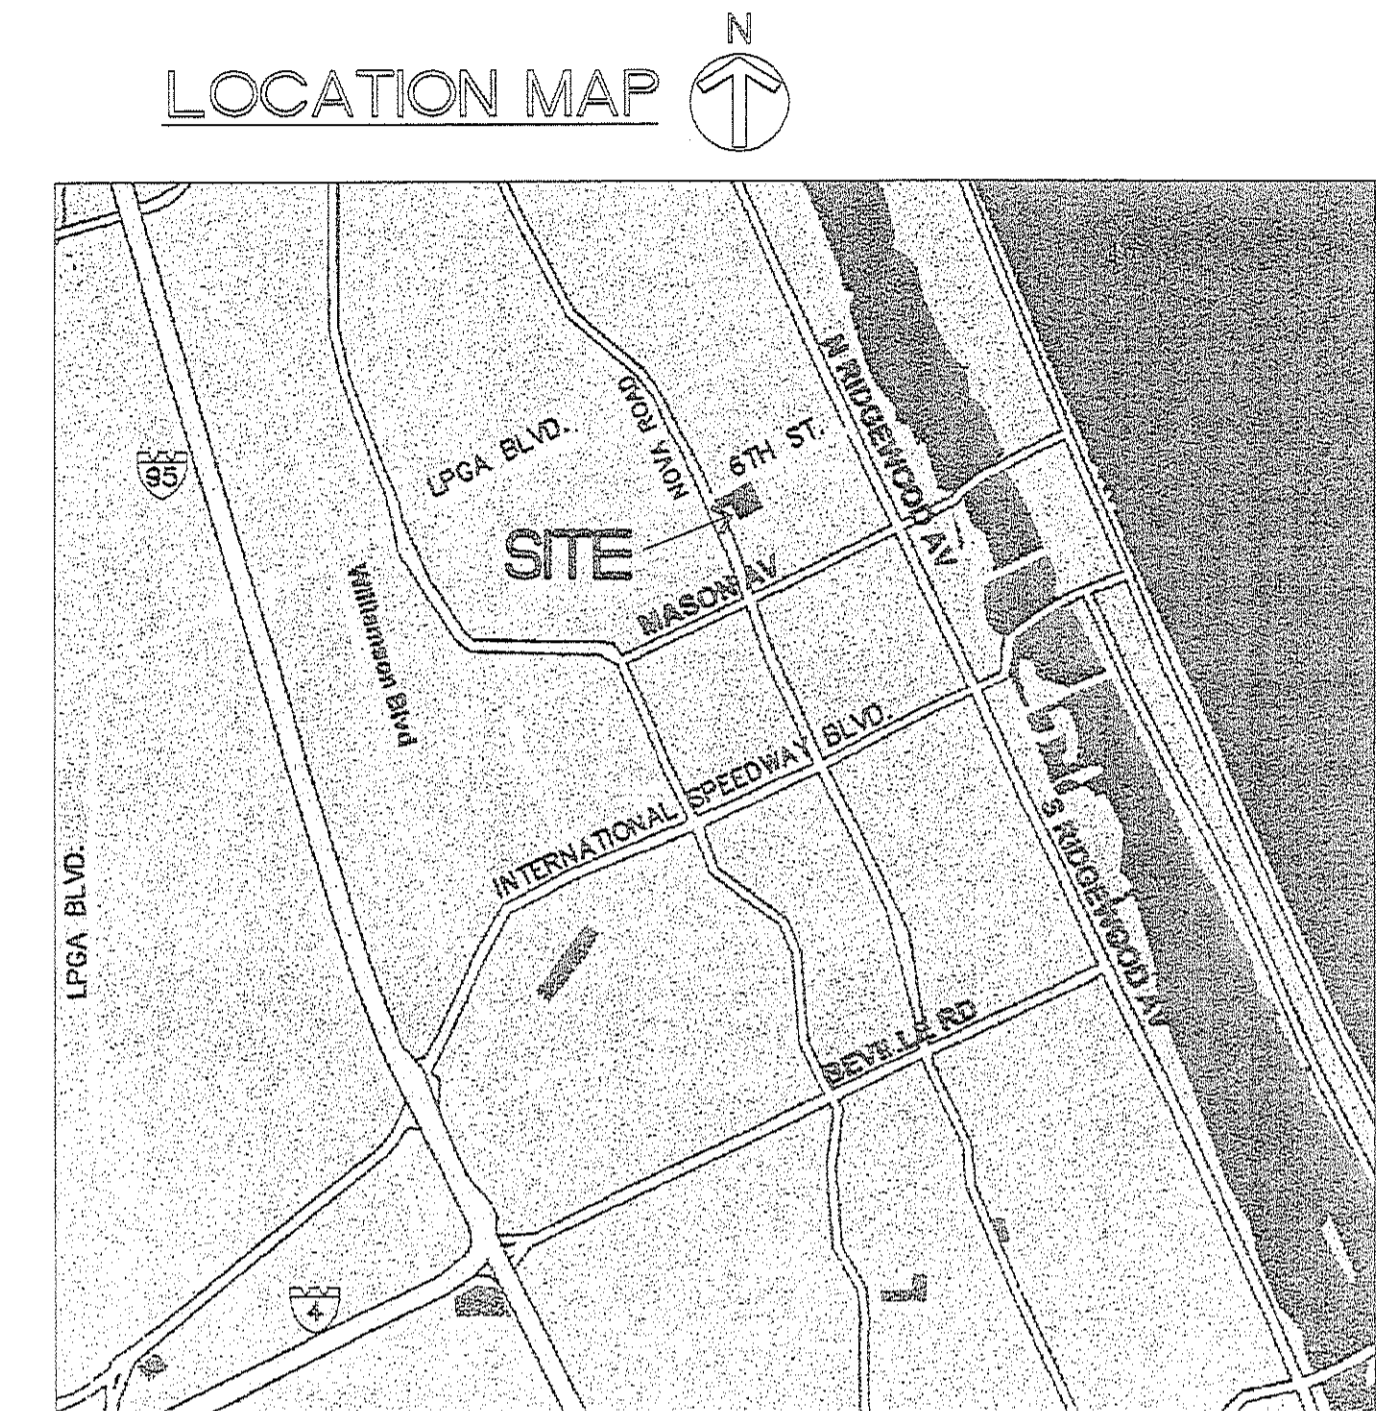

CONSULTANTS

CIVIL
 FINLEY ENGINEERING GROUP
 5921 S. RIVERWAD AVE. UNIT #1
 FORT ORLAND, FLORIDA

STRUCTURAL
 AP CONSULTING ENGINEERS
 1910 N. SEMORAN BLVD. SUITE 102
 ORLANDO, FLORIDA

MECHANICAL
 ENERGY SYSTEMS DESIGN
 750 S. BEACH STREET
 DAYTONA BEACH, FLORIDA

ELECTRICAL
 PAUL M. ESTES, P.E.
 485 N. PENNELLA PK.
 DAYTONA BEACH, FLORIDA


BID DOCUMENTS

SCHEDULE OF DRAWINGS

CS - COVER SHEET	01		
CIVIL		STRUCTURAL	
C-1 - COVER SHEET	02	S1.0 - STRUCTURAL NOTES	17
C-2 - STORMWATER POLLUTION PREVENTION PLAN	03	S2.0 - FOUNDATION PLAN/ NOTES	18
C-3 - CIVIL SITE PLAN	04	S3.0 - FOUNDATION DETAILS	19
C-4 - DETAILS	05		
C-5 - DETAILS	06	MECHANICAL	
SURVEY		FP1.0 - FIRE PROTECTION SITE PLAN	20
S-1 - OVERALL SURVEY/ GENERAL NOTES	07	FP2.0 - FIRE PROTECTION FLOOR PLAN	21
S-2 - PARTIAL SURVEY/ NOTES	08	FP3.0 - SECTIONS	22
S-3 - PARTIAL SURVEY/ NOTES	09	M2.0 - MECH/ PLUMBING PLAN	23
ARCHITECTURAL		ELECTRICAL	
A1.0 - ARCHITECTURAL SITE PLAN	10	E-1.0 - ELECTRICAL FLOOR PLAN	24
A2.0 - ARCHITECTURAL FLOOR PLAN	11		
A2.1 - DIMENSION PLAN/ CANOPY DETAILS	12		
A2.2 - PARTIAL FOUNDATION PLAN/ DETAILS	13		
A3.0 - ELEVATIONS	14		
A3.1 - ELEVATIONS	15		
A4.0 - BUILDING SECTIONS/ DETAILS	16		

9-JULY-2010

HAWKINS, HALL & OGLE
 ARCHITECTS, INC.

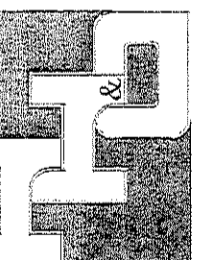

208 MAGNOLIA AVENUE, SUITE 3014
 DAYTONA BEACH, FLORIDA 32114
 PH (904) 255-6103 FAX (904) 255-6691

COMM. NO.

1010

SHEET NO.

CS