


SANITARY SEWER PROFILE
SCALE: 1"=20' HORIZONTAL - 1"=4' VERTICAL

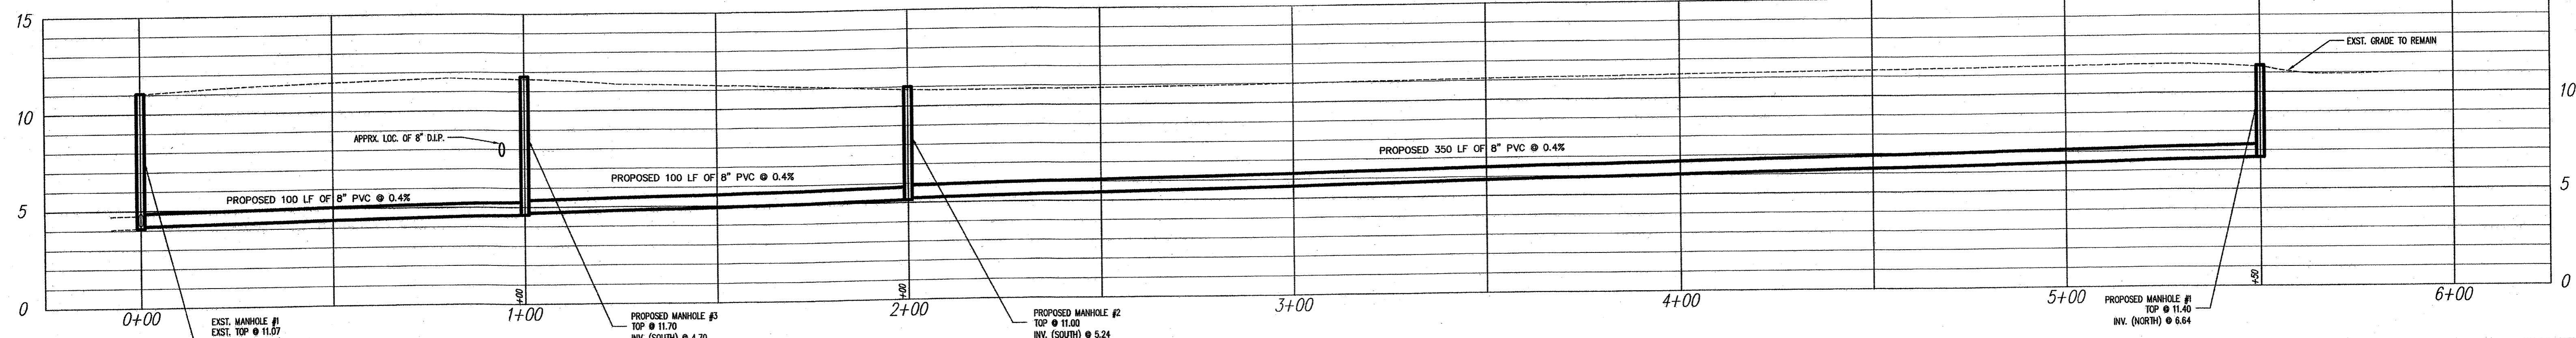

12/27/11	CITY STAFF COMMENTS	NMDJ
10/04/11	CITY STAFF COMMENTS	NMDJ
Revised	Description of Revision	By

Daniel Johns, P.E.
Professional Engineers
3869 S. Nova Rd., Ste. #4, Port Orange, FL 32127
phone: 386-756-8582 / fax: 386-756-0611

OFF-SITE UTILITY PLAN

FRATERNAL ORDER OF EAGLES #4301

324 Beville Road
Daytona Beach, Volusia County, Florida 32114

file: * date: 06-15-11 scale: 1" = 20' sheet: 5 of 19

CITY APPROVAL STAMP (REV2011-107)