


KEY PLAN

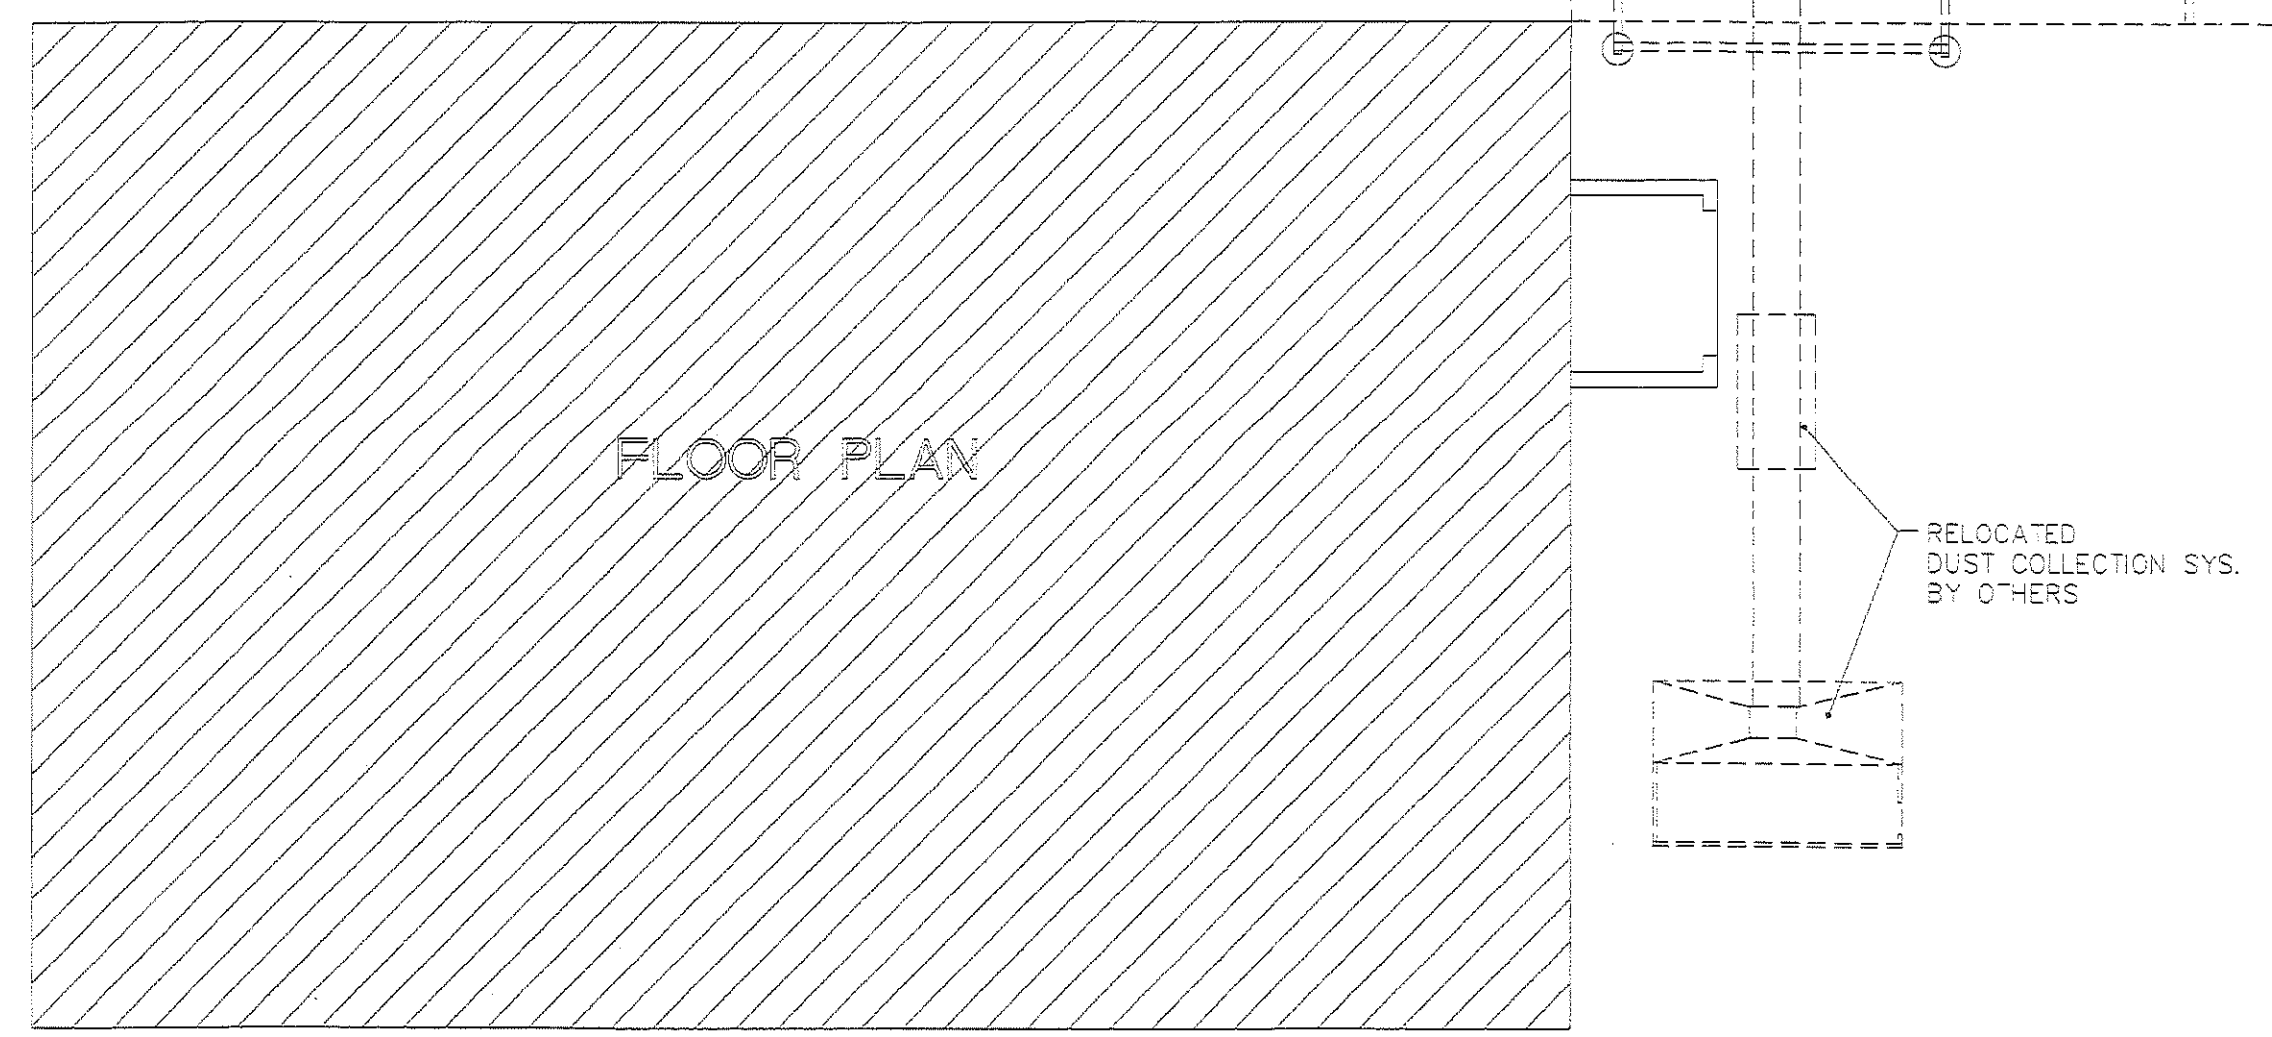

**FIRE PROTECTION PLAN**  
SCALE: 1/8" = 1'-0"

**BID DOCUMENT  
NOT FOR CONSTRUCTION**

**ENERGY SYSTEMS DESIGN, INC**  
ALAN H. LUNDSTROM PE  
PE#19436 AND EQ# 3008  
250 SO. BEACH STREET STE 20  
DAYTONA BEACH FL 32114  
386 250 6703  
e@esd-fl.com

**HAWKINS, HALL & OGLE ARCHITECTS, INC.**  
226 MAGNOLIA AVENUE  
DAYTONA BEACH, FLORIDA 32114  
PH (386) 252-6163 FAX (386) 257-5650

**DAYTONA BEACH NEWS JOURNAL  
NEW WAREHOUSE ADDITION**

NO.	REVISION/ SUBMISSIONS	DATE

SHT. TITLE: NEWSPRINT STORAGE BUILDING

COMMISSION NO. <b>1010</b>	SCALE: 1/8"=1'-0"
DRAWN: AHL/DHR	SHEET NO. <b>FP20</b>
CHECKED: AHL	DATE: JULY 9, 2010
	CF