



SKY LOUNGE FLOOR PLAN  
SCALE: 1/4"=1'-0"

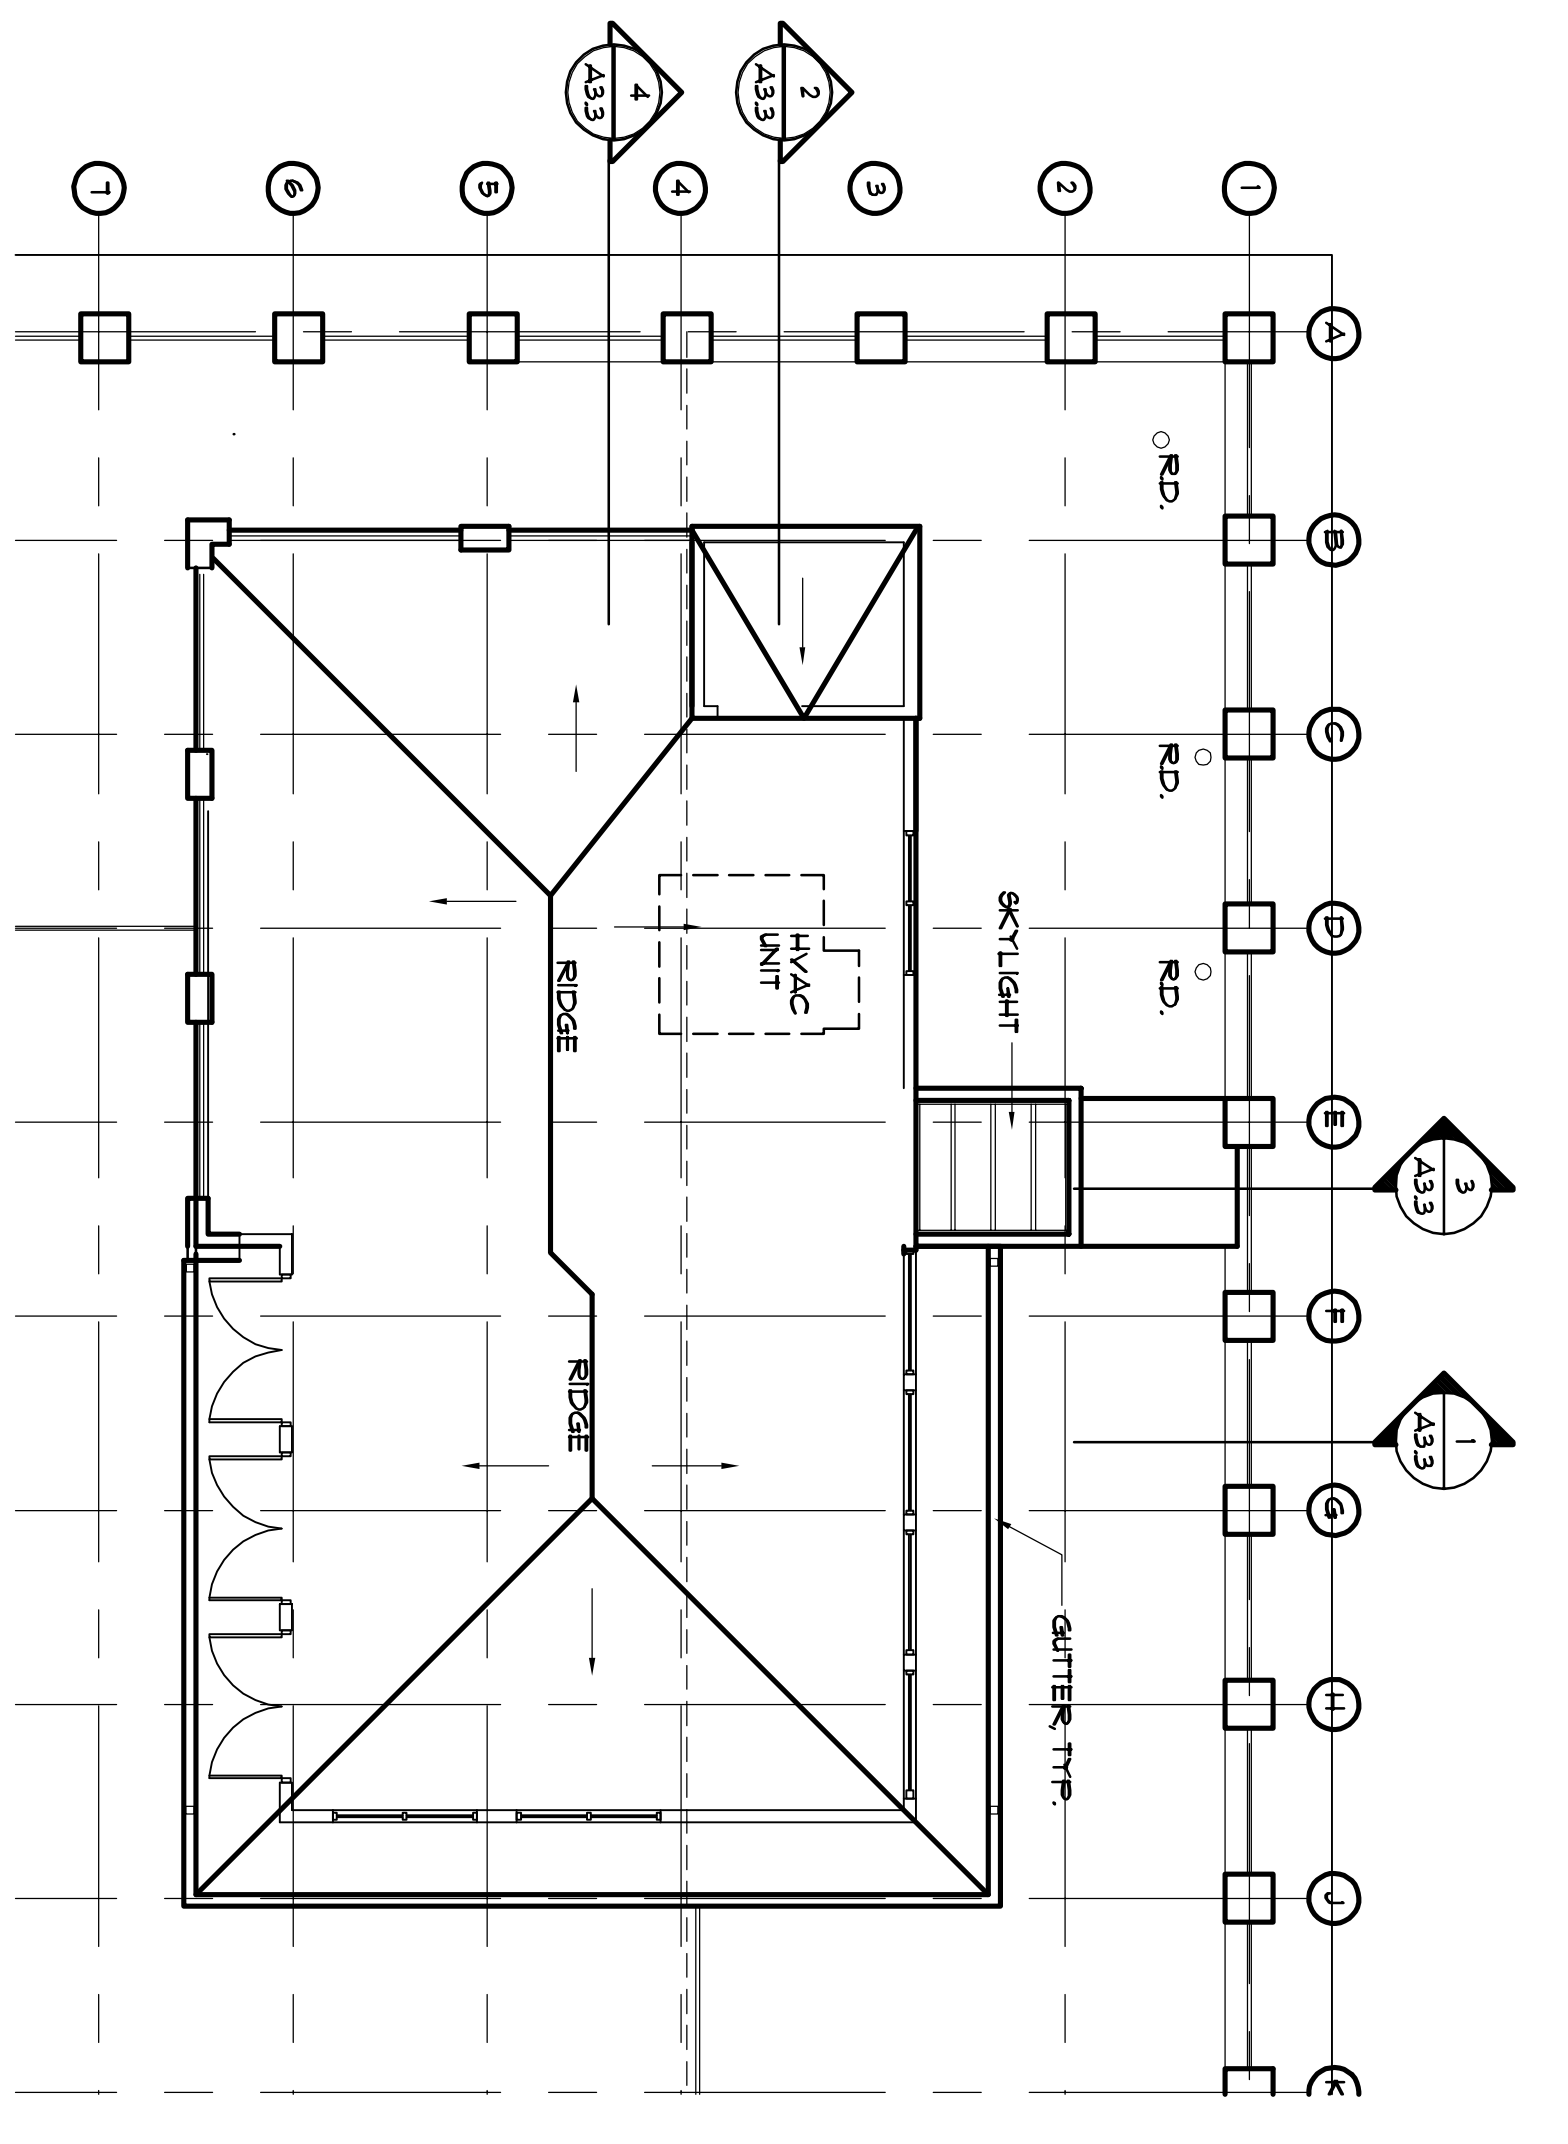

SKY LOUNGE ROOF PLAN  
SCALE: 1/8"=1'-0"

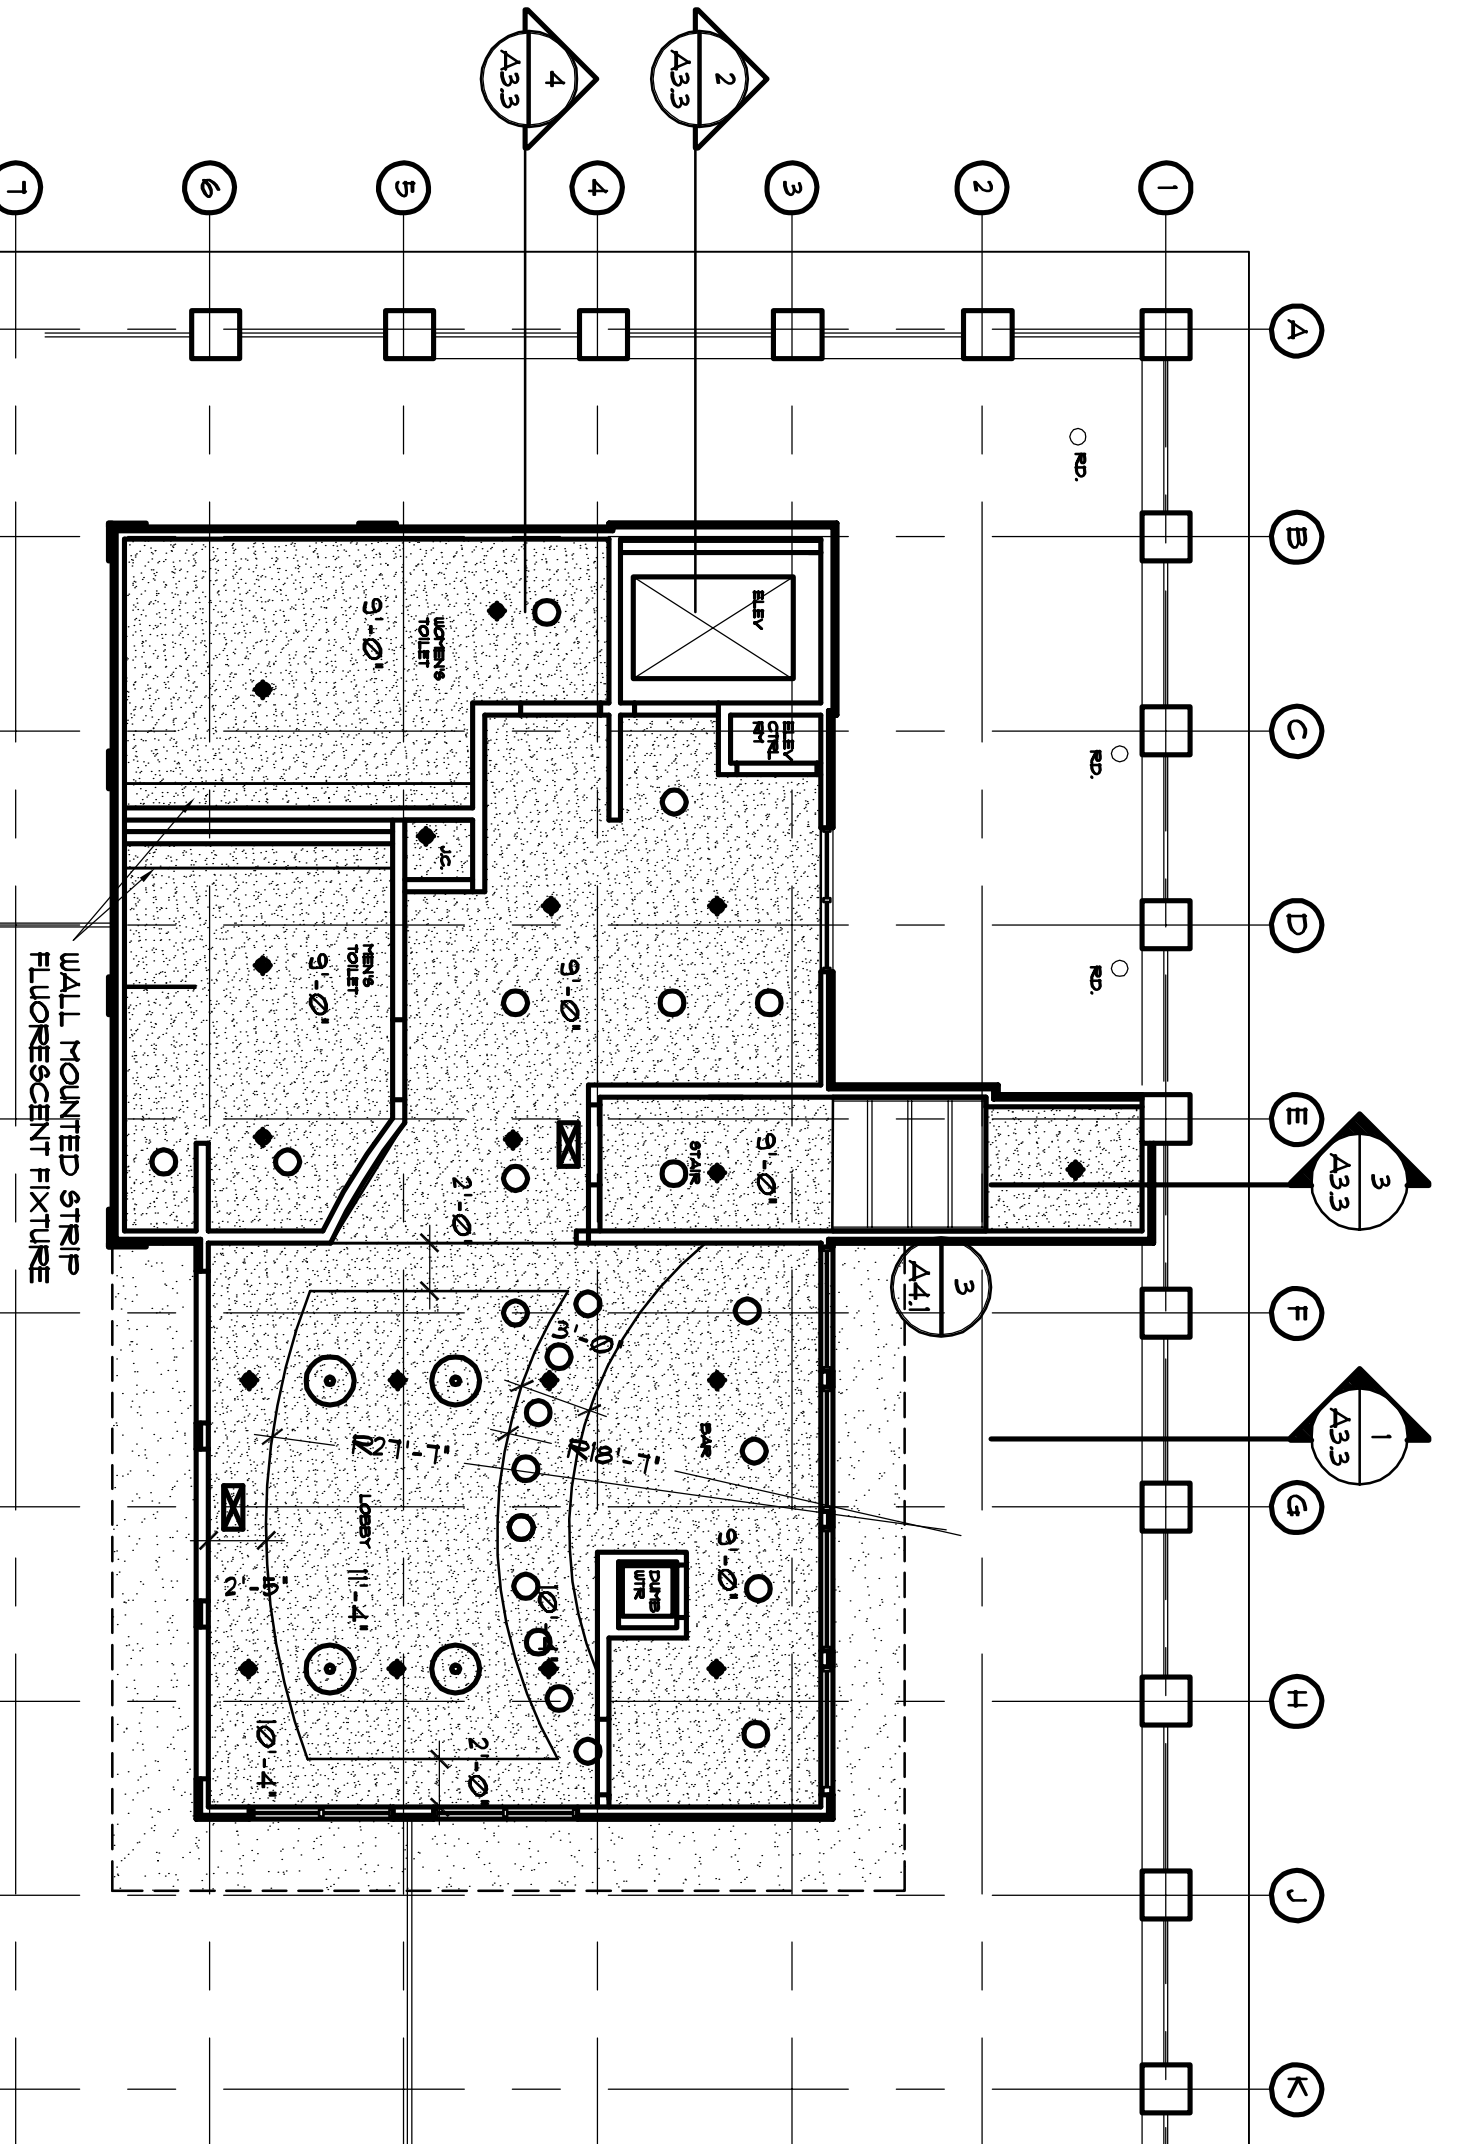


SKY LOUNGE REFLECTED CEILING PLAN  
SCALE: 1/8"=1'-0"

CEILING LEGEND	
	EXIT LIGHT
	SPRINKLER HEAD
	RECESSED CAN LIGHT
	PENDANT MOUNTED BOWL LIGHT

# DAYTONA BEACH PIER BUILDING RENOVATION

MAIN STREET  
DAYTONA BEACH, FL

918 NORTH NOVA RD.  
HOLLY HILL, FL 32117  
AA 26000567  
PHONE (386) 255-6987  
FAX (386) 255-6986

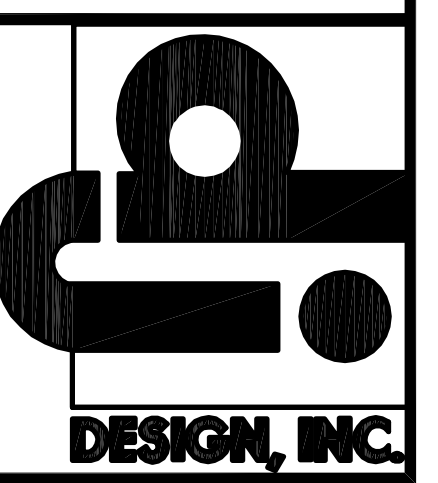

REV	REVISIONS	DATE

PJT#: 02126.11  
 DATE: 06/30/10  
 DRN BY: HKC  
 DGN BY: DMS  
 REV BY: DMS  
 SCALE: AS NOTED

SHEET  
**A4.1**  
 SKY LOUNGE PLANS