

1 LEVEL 1 REFLECTED CEILING PLAN
1/8" = 1'-0"

GENERAL RCP NOTES

1. ALL STROBES SHALL BE LOCATED @ 8'-0" AFF. SEE ENGINEER'S DRAWINGS FOR LOCATIONS AND SPECIFICATIONS.
2. ALL STROBES TO ALIGN VERTICALLY WITH RECEPTACLE BELOW WHERE OCCURS.
3. ARCHITECT TO REVIEW ALL LIGHT/CEILING FIXTURE LOCATIONS PRIOR TO INSTALLATION.
4. INSTALL THE SUSPENDED CEILING GRID TO BE LEVEL WITHIN A TOLERANCE OF 1/8" IN 12'-0". ANCHOR AS REQUIRED.
5. ARCHITECT TO REVIEW LOCATIONS OF ALL SLOT DIFFUSERS, SPRINKLERS, SMOKE DETECTORS, ETC. IN GYP BOUCELINGS.
6. WHERE ACOUSTICAL PANELS ARE REQUIRED TO BE CUT, CUT THE PANELS TO MAINTAIN A SHARP AND NEAT EDGE.
7. INSTALL NEW SPRINKLER HEADS AND LIGHT FIXTURES AT THE CENTER OF THE ACOUSTICAL CEILING PANEL UNON.
8. MEP & FP TO COMPLY WITH ALL APPLICABLE CODES AND SUBMIT SHOP DRAWINGS FOR ARCHITECT REVIEW OF ALL LOCATIONS OF DEVICES PRIOR TO INSTALLATION.
9. RELOCATE EXISTING SPRINKLER HEADS IN ACCORDANCE WITH APPLICABLE CODES AS REQUIRED TO COORDINATE WITH NEW CONSTRUCTION.

KEYED NOTES

19. OWNER FURNISHED OWNER INSTALLED CEILING MOUNTED PROJECTOR. PROVIDE POWER AND DATA ABOVE CEILING WITH MIN 6'-0" WHIP. INSTALL DUPLEX OUTLET IN CEILING FOR PROJECTOR POWER. PROVIDE DUPLEX OUTLET IN CEILING DIRECTLY ABOVE WALL MOUNTED EXTRON PANEL. COORDINATE WITH AV VENDOR.
20. OWNER FURNISHED CONTRACTOR INSTALLED CEILING MOUNTED PROJECTION SCREEN. PROVIDE POWER AND DATA ABOVE CEILING WITH MIN 6'-0" WHIP. ELECTRICAL CONTRACTOR TO HARD WIRE PROJECTION SCREEN.

RCP LEGEND

- 2' X 2' GRID AND TILE SYSTEM - SEE SPECIFICATIONS
- GYPSUM BOARD CEILING AS INDICATED ON PLAN. SEE FINISH PLAN FOR PAINT SPECS.
- 8'-6" AFF FINISHED CEILING HEIGHT AS INDICATED ON PLAN UNON
- CEILING MOUNTED EXIT SIGN
- F1 2x4' RECESSED FLUORESCENT LIGHT FIXTURE LIGHT TOLUOL - COFFAIRE II STATIC 2 LAMP S.O. T5
- F10 2x4' RECESSED FLUORESCENT LIGHT FIXTURE LIGHT TOLUOL - COFFAIRE II STATIC 2 LAMP S.O. T5 DIMMABLE BALLAST
- F3 6" RECESSED DOWN LIGHT COVENTRY - 6HF1
- F30 PER F3 WITH DIMMABLE BALLAST
- F3W PER F3 WITH WALL WASHER TRIM REFLECTOR
- F4 2' RECESSED LINEAR WALL WASH LIGHT FIXTURE FOCAL POINT - AVENUE A 14W T5
- F40 PER F4 WITH DIMMABLE BALLAST
- F5 DECORATIVE PENDANT HIVE LE KLINT LK172 SMALL 13" DIAMETER BOTTOM OF PENDANT AT 8'0" AFF
- F60 4' RECESSED LINEAR REGRESSED LENS FLUORESCENT FIXTURE FOCAL POINT AVENUE G 28W T5 DIMMABLE BALLAST
- F7 WALL SCONCE OXYGEN LIGHTING PEBBLE WALL SCONCE 23156-124 1 X 18W QUAD 4-PIN FLUORESCENT



Project
Humana Daytona Market Office
143 EXECUTIVE CIRCLE
DAYTONA, FL 32114

Prepared For
Humana, Inc.
Client Location

Contract No: 10.01698.00




HOJK
211 N. Broadway Suite 700
St. Louis, MO 63110 USA
t +1 314 421 2000 f +1 314 421 6073

FL Reg: AAC001139
All reproduction & intellectual property rights reserved © 2011
In Association with



SDM Consulting Engineers
ME/FP Engineer
135 Almeria Avenue
Coral Gables, FL 33134
P: 305.446.2788
F: 305.443.5944
www.sdmcorp.com/contact

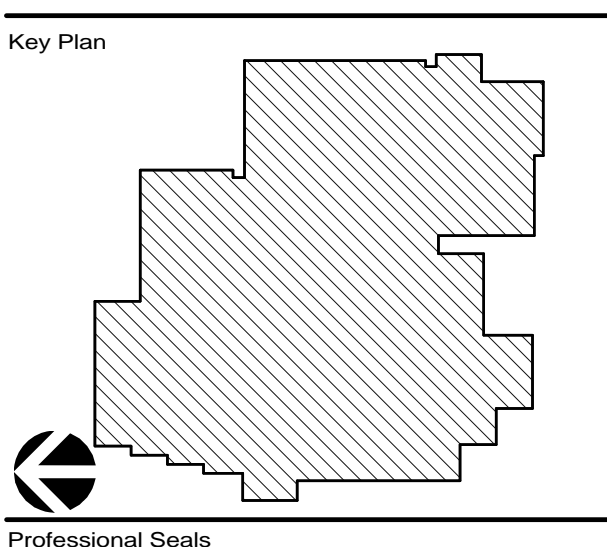

No.	Issue Description	YYYY-MM-DD
2	ISSUE FOR BID & PERMIT	12.14.11

No.	Revision Description	YYYY-MM-DD
1	Bulletin 2	01.26.12

Drawn by Author Reviewed by Checker
Project No 10.01698.00

Sheet Title
LEVEL 1 REFLECTED CEILING PLAN

Original drawing is 42 x 30 Do not scale contents of this drawing
Sheet Number

A301