


Project  
**Humana Daytona Market**  
 Office  
 148 EXECUTIVE CIRCLE  
 DAYTONA, FL 32114

Prepared For  
**Humana, Inc.**  
 Client Location

Contact No: 10.01688.00

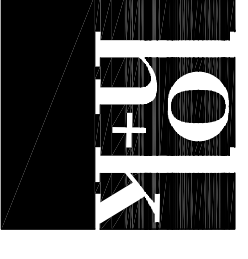

HOK  
 2700 Broadway, Suite 700  
 St. Louis, MO 63110 USA  
 T +1 314 421 2000 F +1 314 421 6073


FL Reg. MAC001139

AN AFFILIATION OF THE INTERNATIONAL ASSOCIATION OF ENGINEERS © 2011




SDM Consulting Engineers  
 16505 E. 1st Avenue  
 Coral Gables, FL 33134  
 P: 305 446 2788  
 F: 305 446 2789  
 www.sdmcpe.com  
 EB-00003731

Key Plan

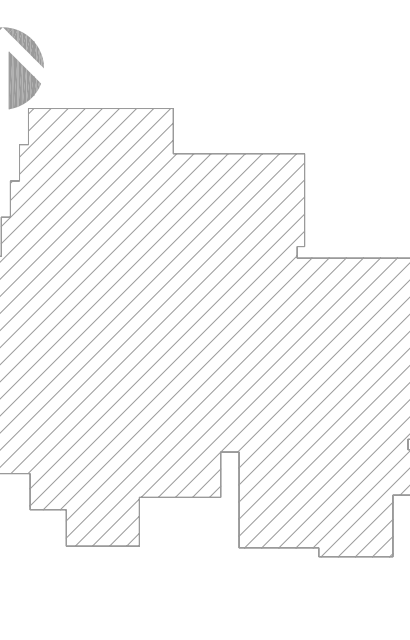

Professional Seals

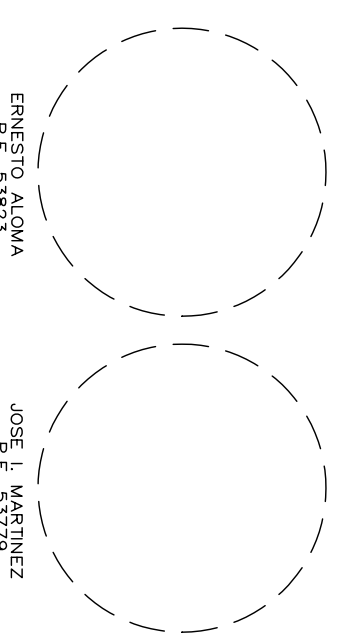


No. Issue Description 12.14.11  
 2 ISSUE FOR BID & PERMIT

No.	Revision Description	YYYY-MM-DD
1	BULLETIN 2	01.28.12
	Revision Description	YYYY-MM-DD
	BULLETIN 2	01.28.12

Drawn by	Author	Reviewed by	Checker
Project No: 10.01688.00			
Sheet Title			

**HVAC ROOF PLAN**

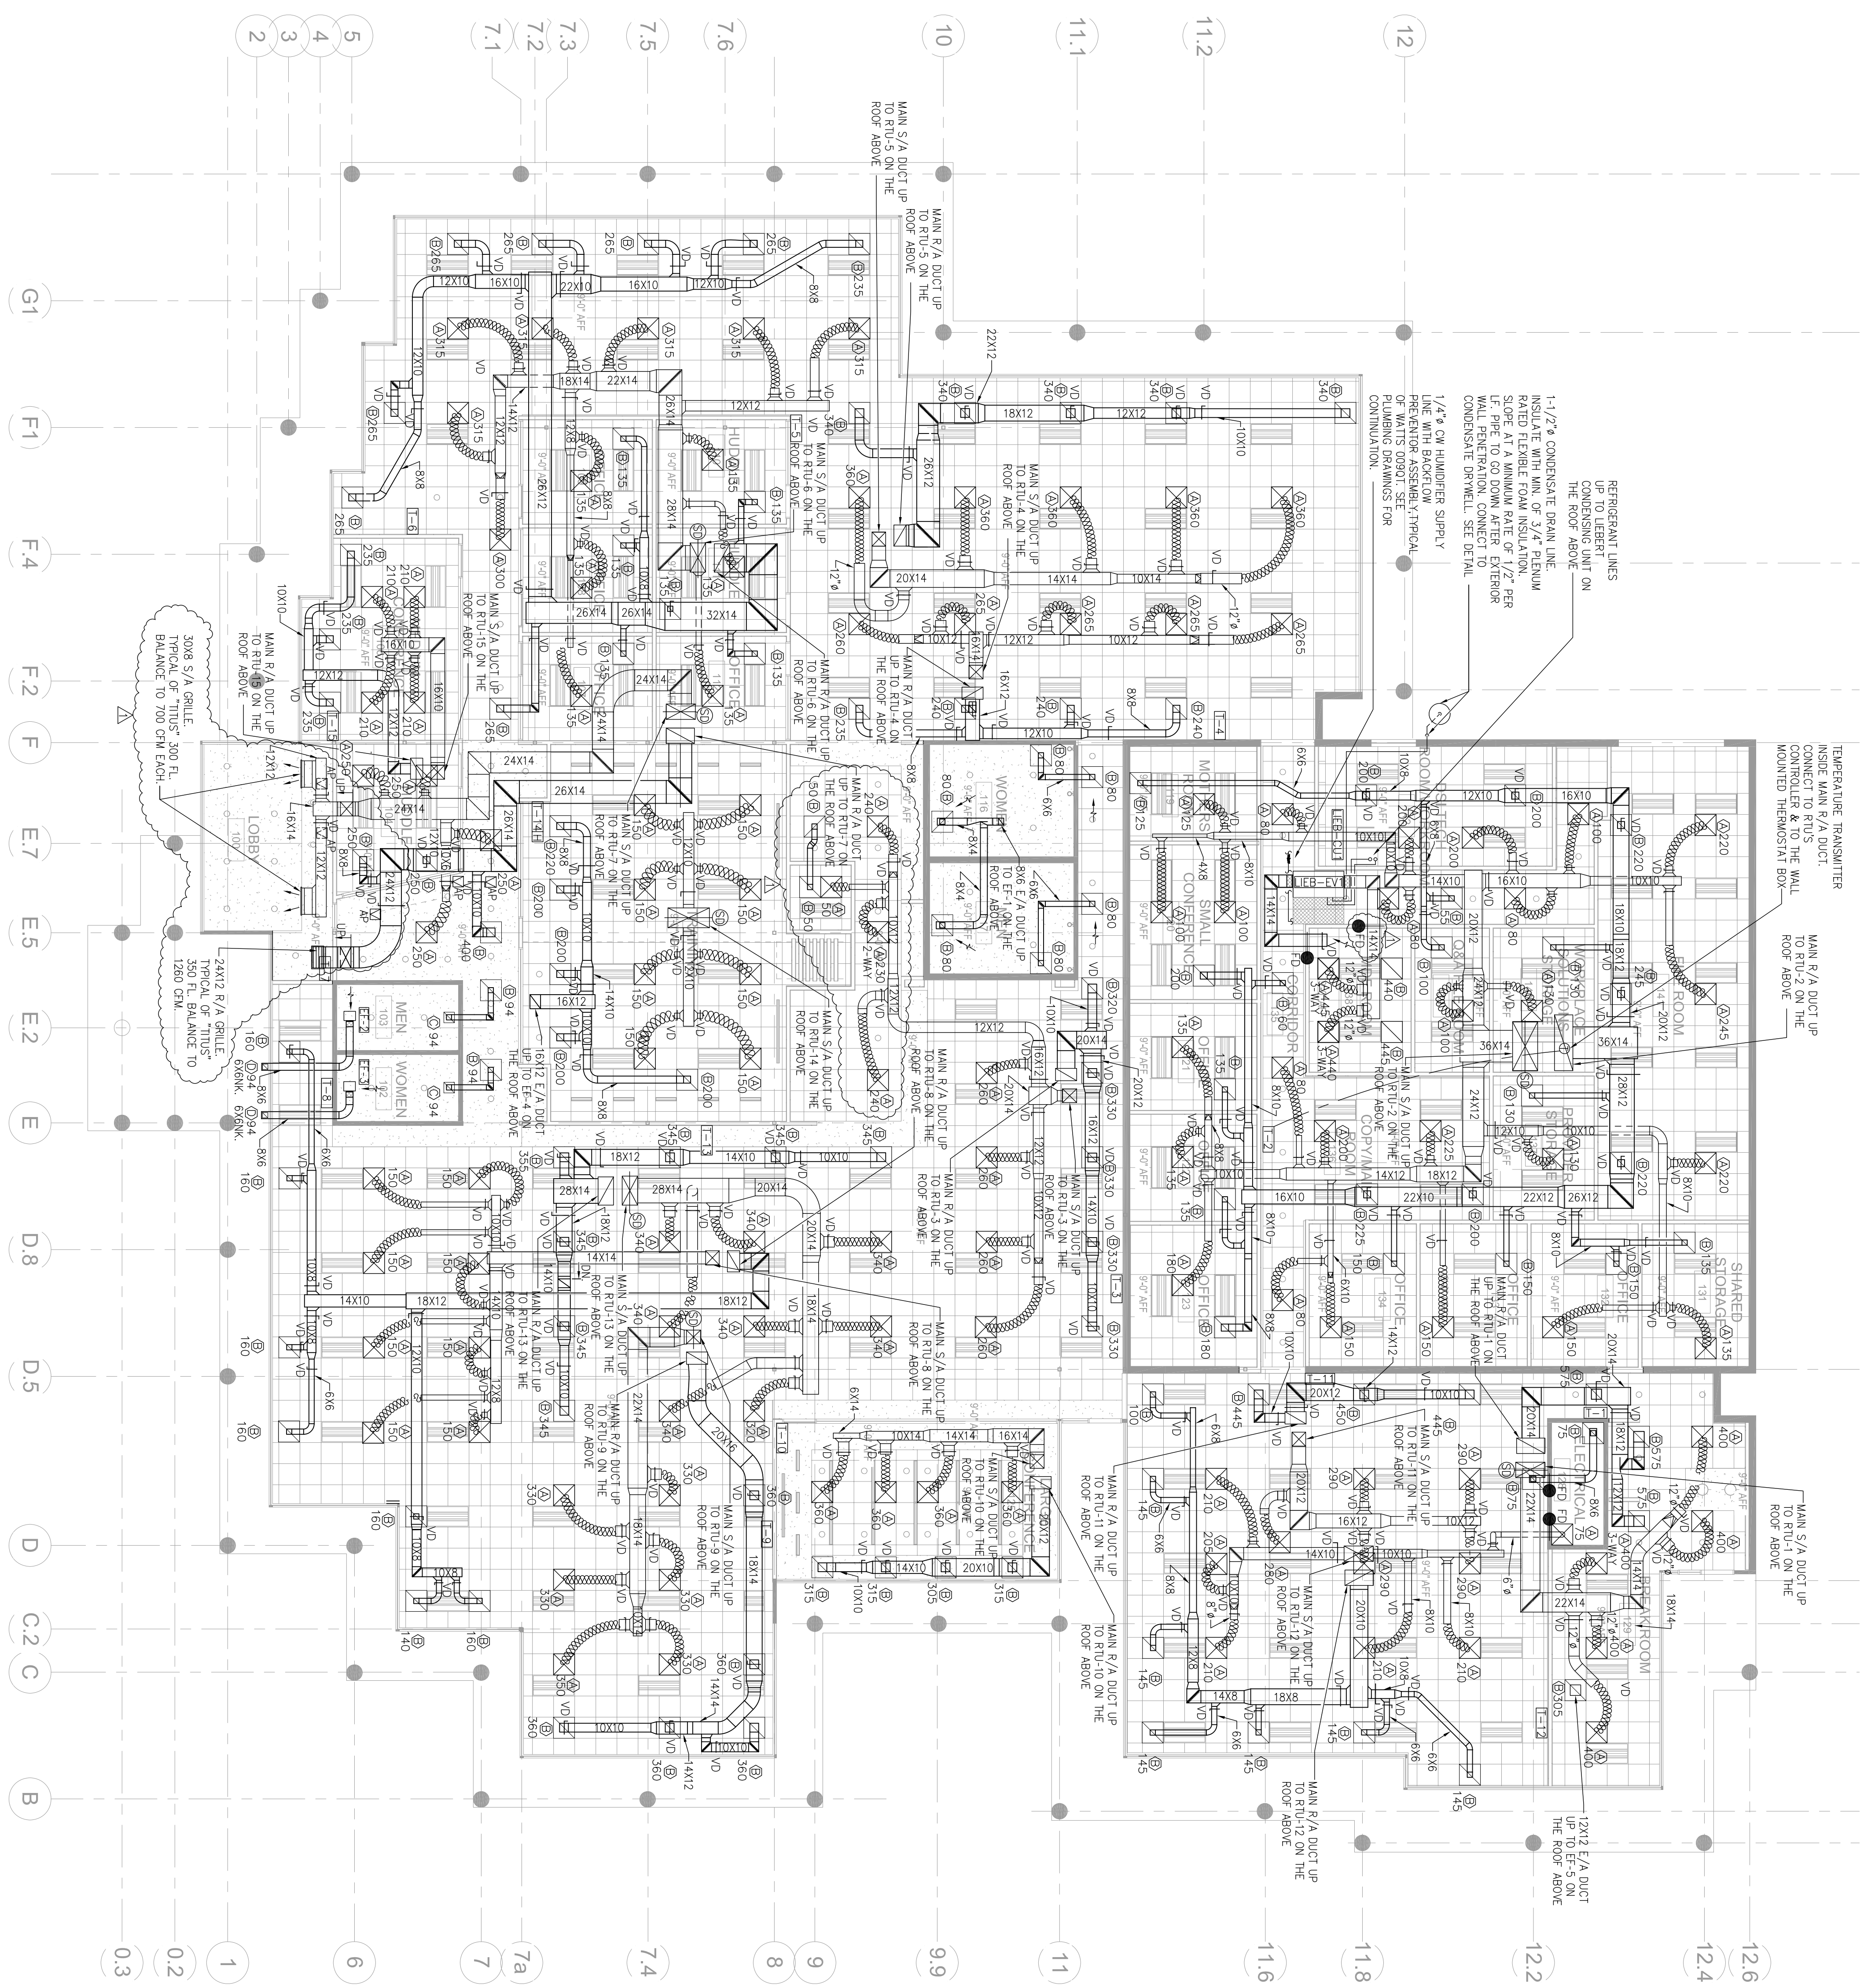

- NOTES**
1. CONTRACTOR TO FIELD VERIFY EXISTING HVAC EQUIPMENT LOCATIONS AND PENETRATIONS AND TO COORDINATE WITH DESIGN PROPOSED DUCTWORK LAYOUT.
  2. DESIGN PROPOSED DUCTWORK LAYOUT AND PROPOSED EQUIPMENT LAYOUT AND DESIGN PROPOSED ROOF PENETRATIONS AND PENETRATIONS WITH THE EXISTING STRUCTURAL MEMBERS TO AVOID ANY CONFLICTS WITH SAME.
  3. CONTRACTOR SHALL LOCATE DESIGN PROPOSED ROOF TOP UNITS FOLLOWING MANUFACTURER CLEARANCES AND INSTALLATION REQUIREMENTS. PROVIDE 2\"/>

**1 HVAC PLAN**

